

TECHNOLOGY SCHEDULE	
EQUIPMENT DESCRIPTION	REMARKS
58 65" TV	TECHNOLOGY
61 INSTRUCTOR STATION	TECHNOLOGY
83 CEILING MOUNTED SPEAKERS/CAMERA	TECHNOLOGY
84 65" TV - VERTICAL	TECHNOLOGY
85 65" TV	TECHNOLOGY
86 75" TV	TECHNOLOGY

ALL FURNITURE SHOWN IS UDCWO AND SHOWN FOR REFERENCE ONLY

Read and understand Specification Divisions 00 & 01 and appropriate technical Specification Sections applicable to perform the work shown on this drawing sheet. Notify Architect/Engineer of any inconsistencies.


PROJECT #: FG2301FG
DATE: 12/18/2024
DRAWN BY: JRZ
CHECKED BY: KMR, RAW

© 2024 RLE

1 MAIN FLOOR TECHNOLOGY PLAN
SCALE: 1/16" = 1'-0"
NORTH

TECHNOLOGY SCHEDULE	
EQUIPMENT DESCRIPTION	REMARKS
58 85" TV	TECHNOLOGY
61 INSTRUCTOR STATION	TECHNOLOGY
83 CEILING MOUNTED SPEAKERS/CAMERA	TECHNOLOGY
84 65" TV - VERTICAL	TECHNOLOGY
85 65" TV	TECHNOLOGY
86 75" TV	TECHNOLOGY

ALL FURNITURE SHOWN IS UDCWO AND SHOWN FOR REFERENCE ONLY

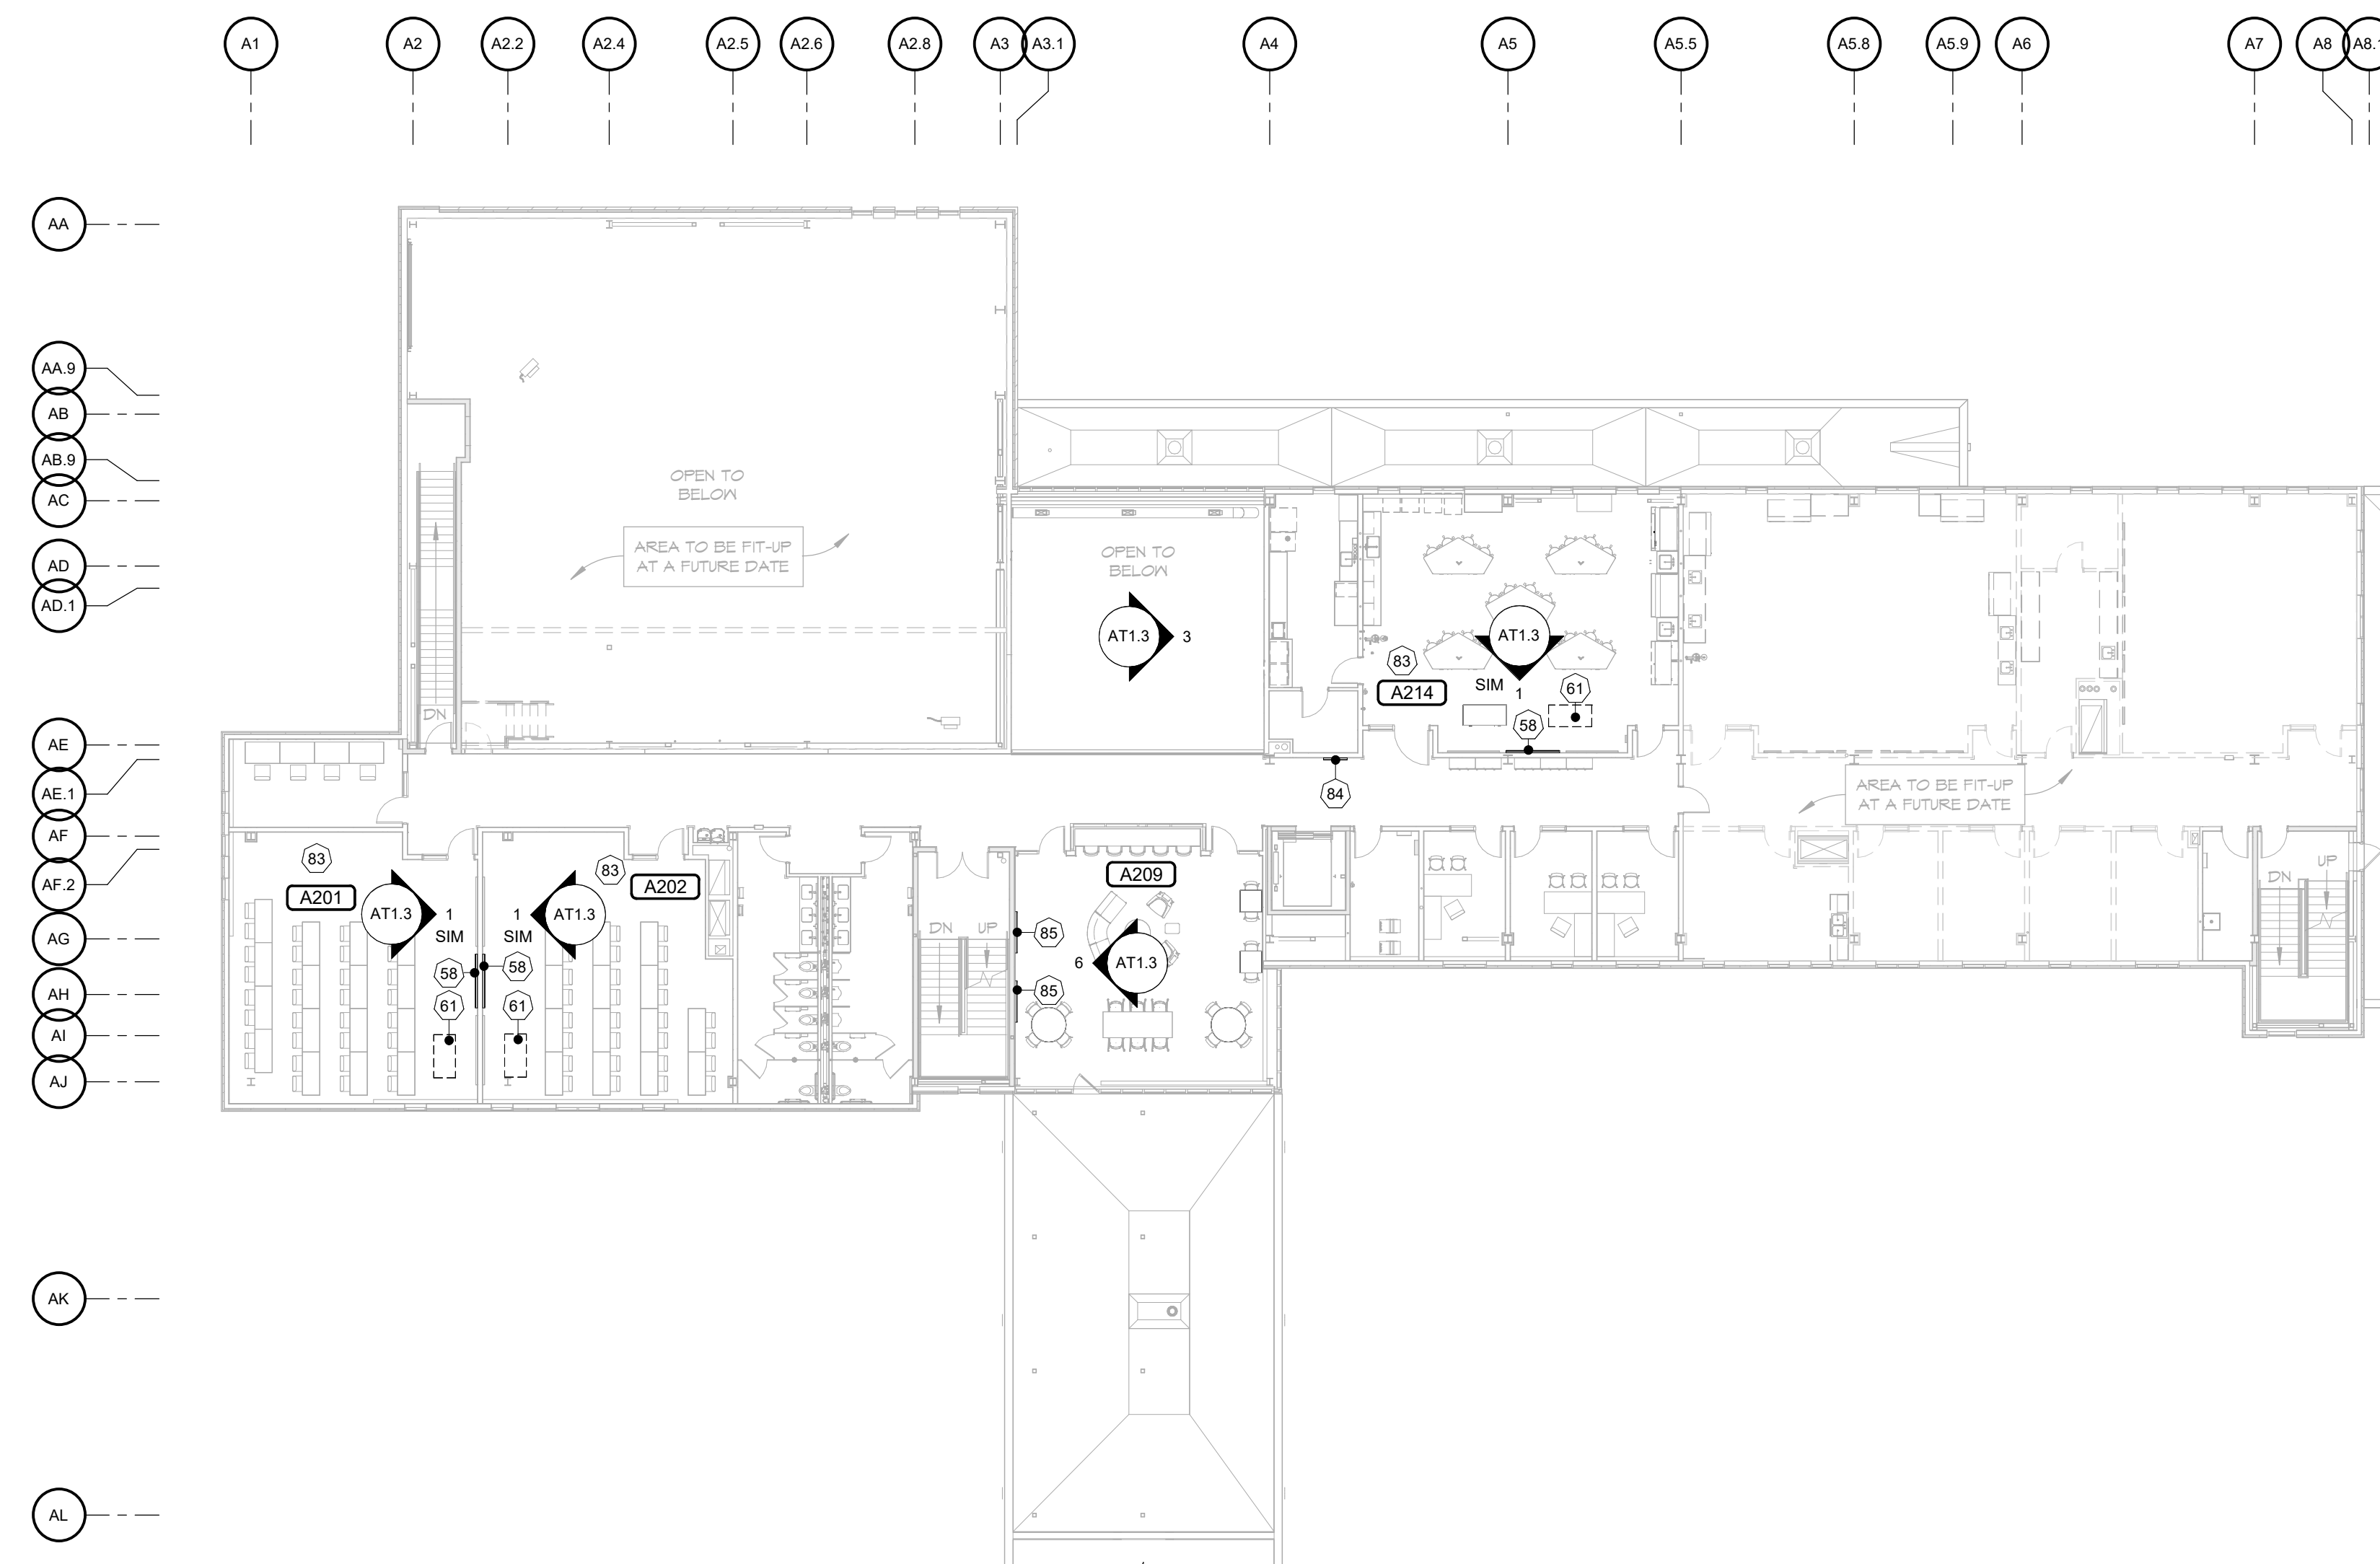

1 SECOND FLOOR TECHNOLOGY PLAN
SCALE: 1/16" = 1'-0"
0' 4' 8' 16' 32'

AT1.2

I hereby certify that this plan, specification, or report was prepared by me or under my direct supervision and that I am a duly Registered Architect under the laws of the State of North Dakota.

Richard A. Wernken
Richard A. Wernken


Dated: 12/18/24 Reg. No. 1207




4230 64TH AVENUE SOUTH
FARGO, NORTH DAKOTA

TECHNOLOGY PACKAGE
REVISIONS


TECHNOLOGY SCHEDULE		
	EQUIPMENT DESCRIPTION	REMARKS
53	85" TV	TECHNOLOGY
61	INSTRUCTOR STATION	TECHNOLOGY
83	CEILING MOUNTED SPEAKERS/CAMERA	TECHNOLOGY
84	65" TV - VERTICAL	TECHNOLOGY
85	65" TV	TECHNOLOGY
86	75" TV	TECHNOLOGY

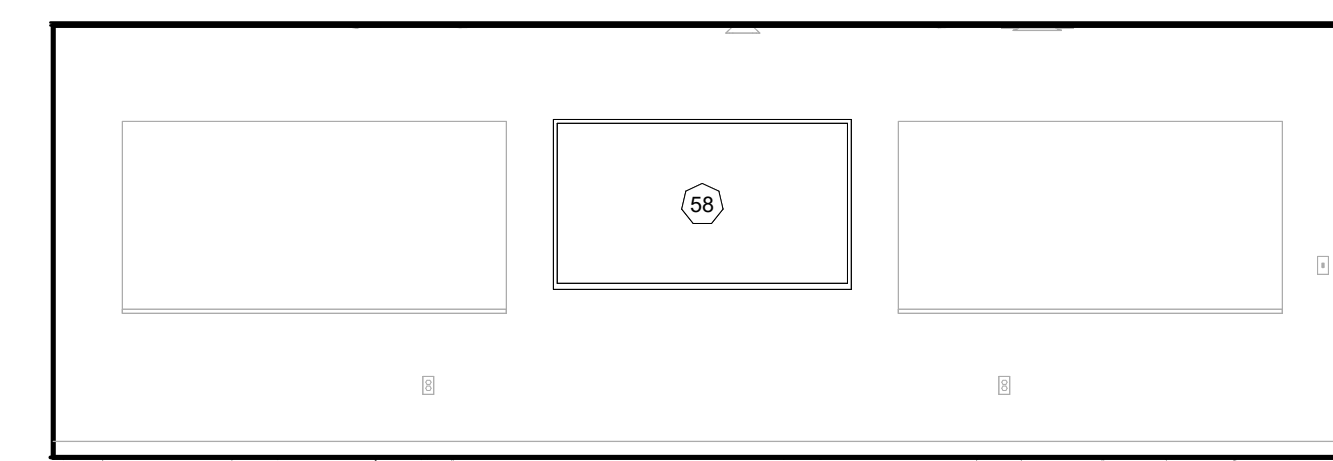


1 TYPICAL CLASSROOM ELEVATION
AT1.3 SCALE: 1/4" = 1'-0"

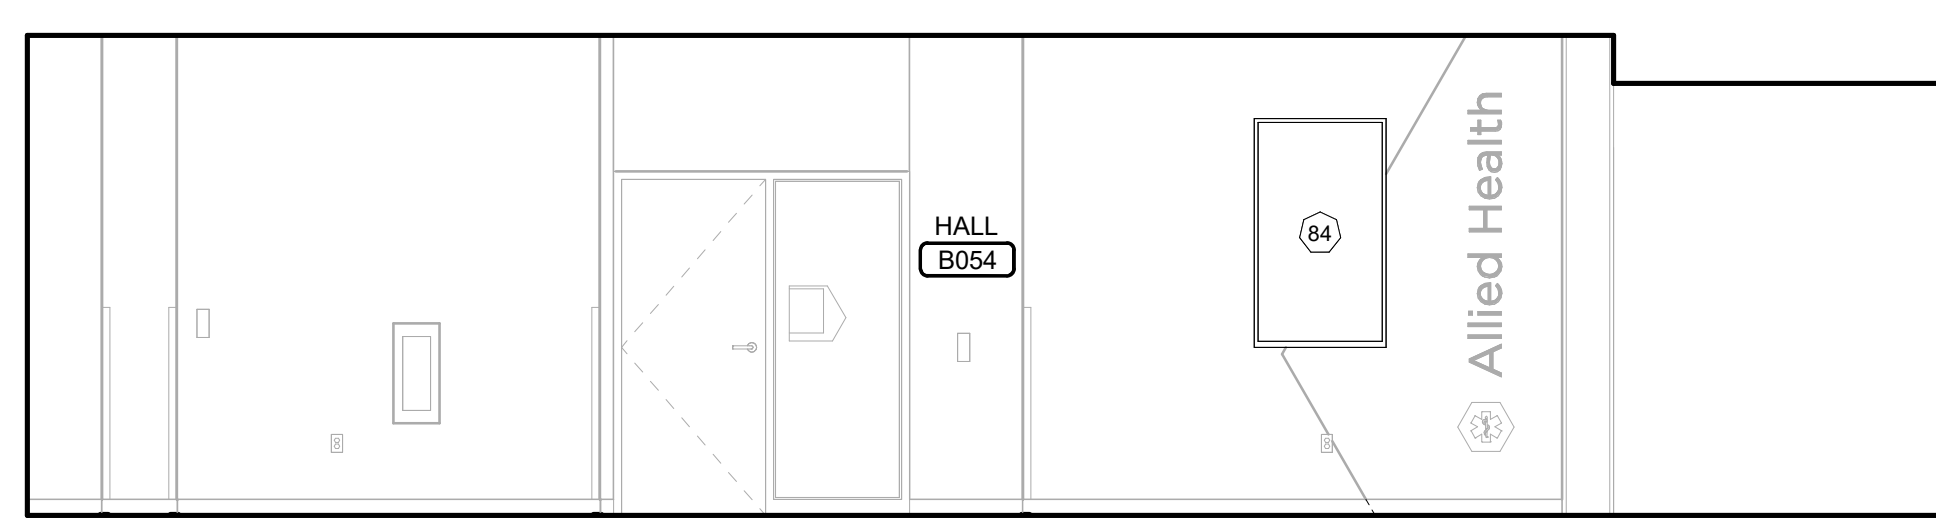


2 HALL ELEVATION
AT1.3 SCALE: 1/4" = 1'-0"

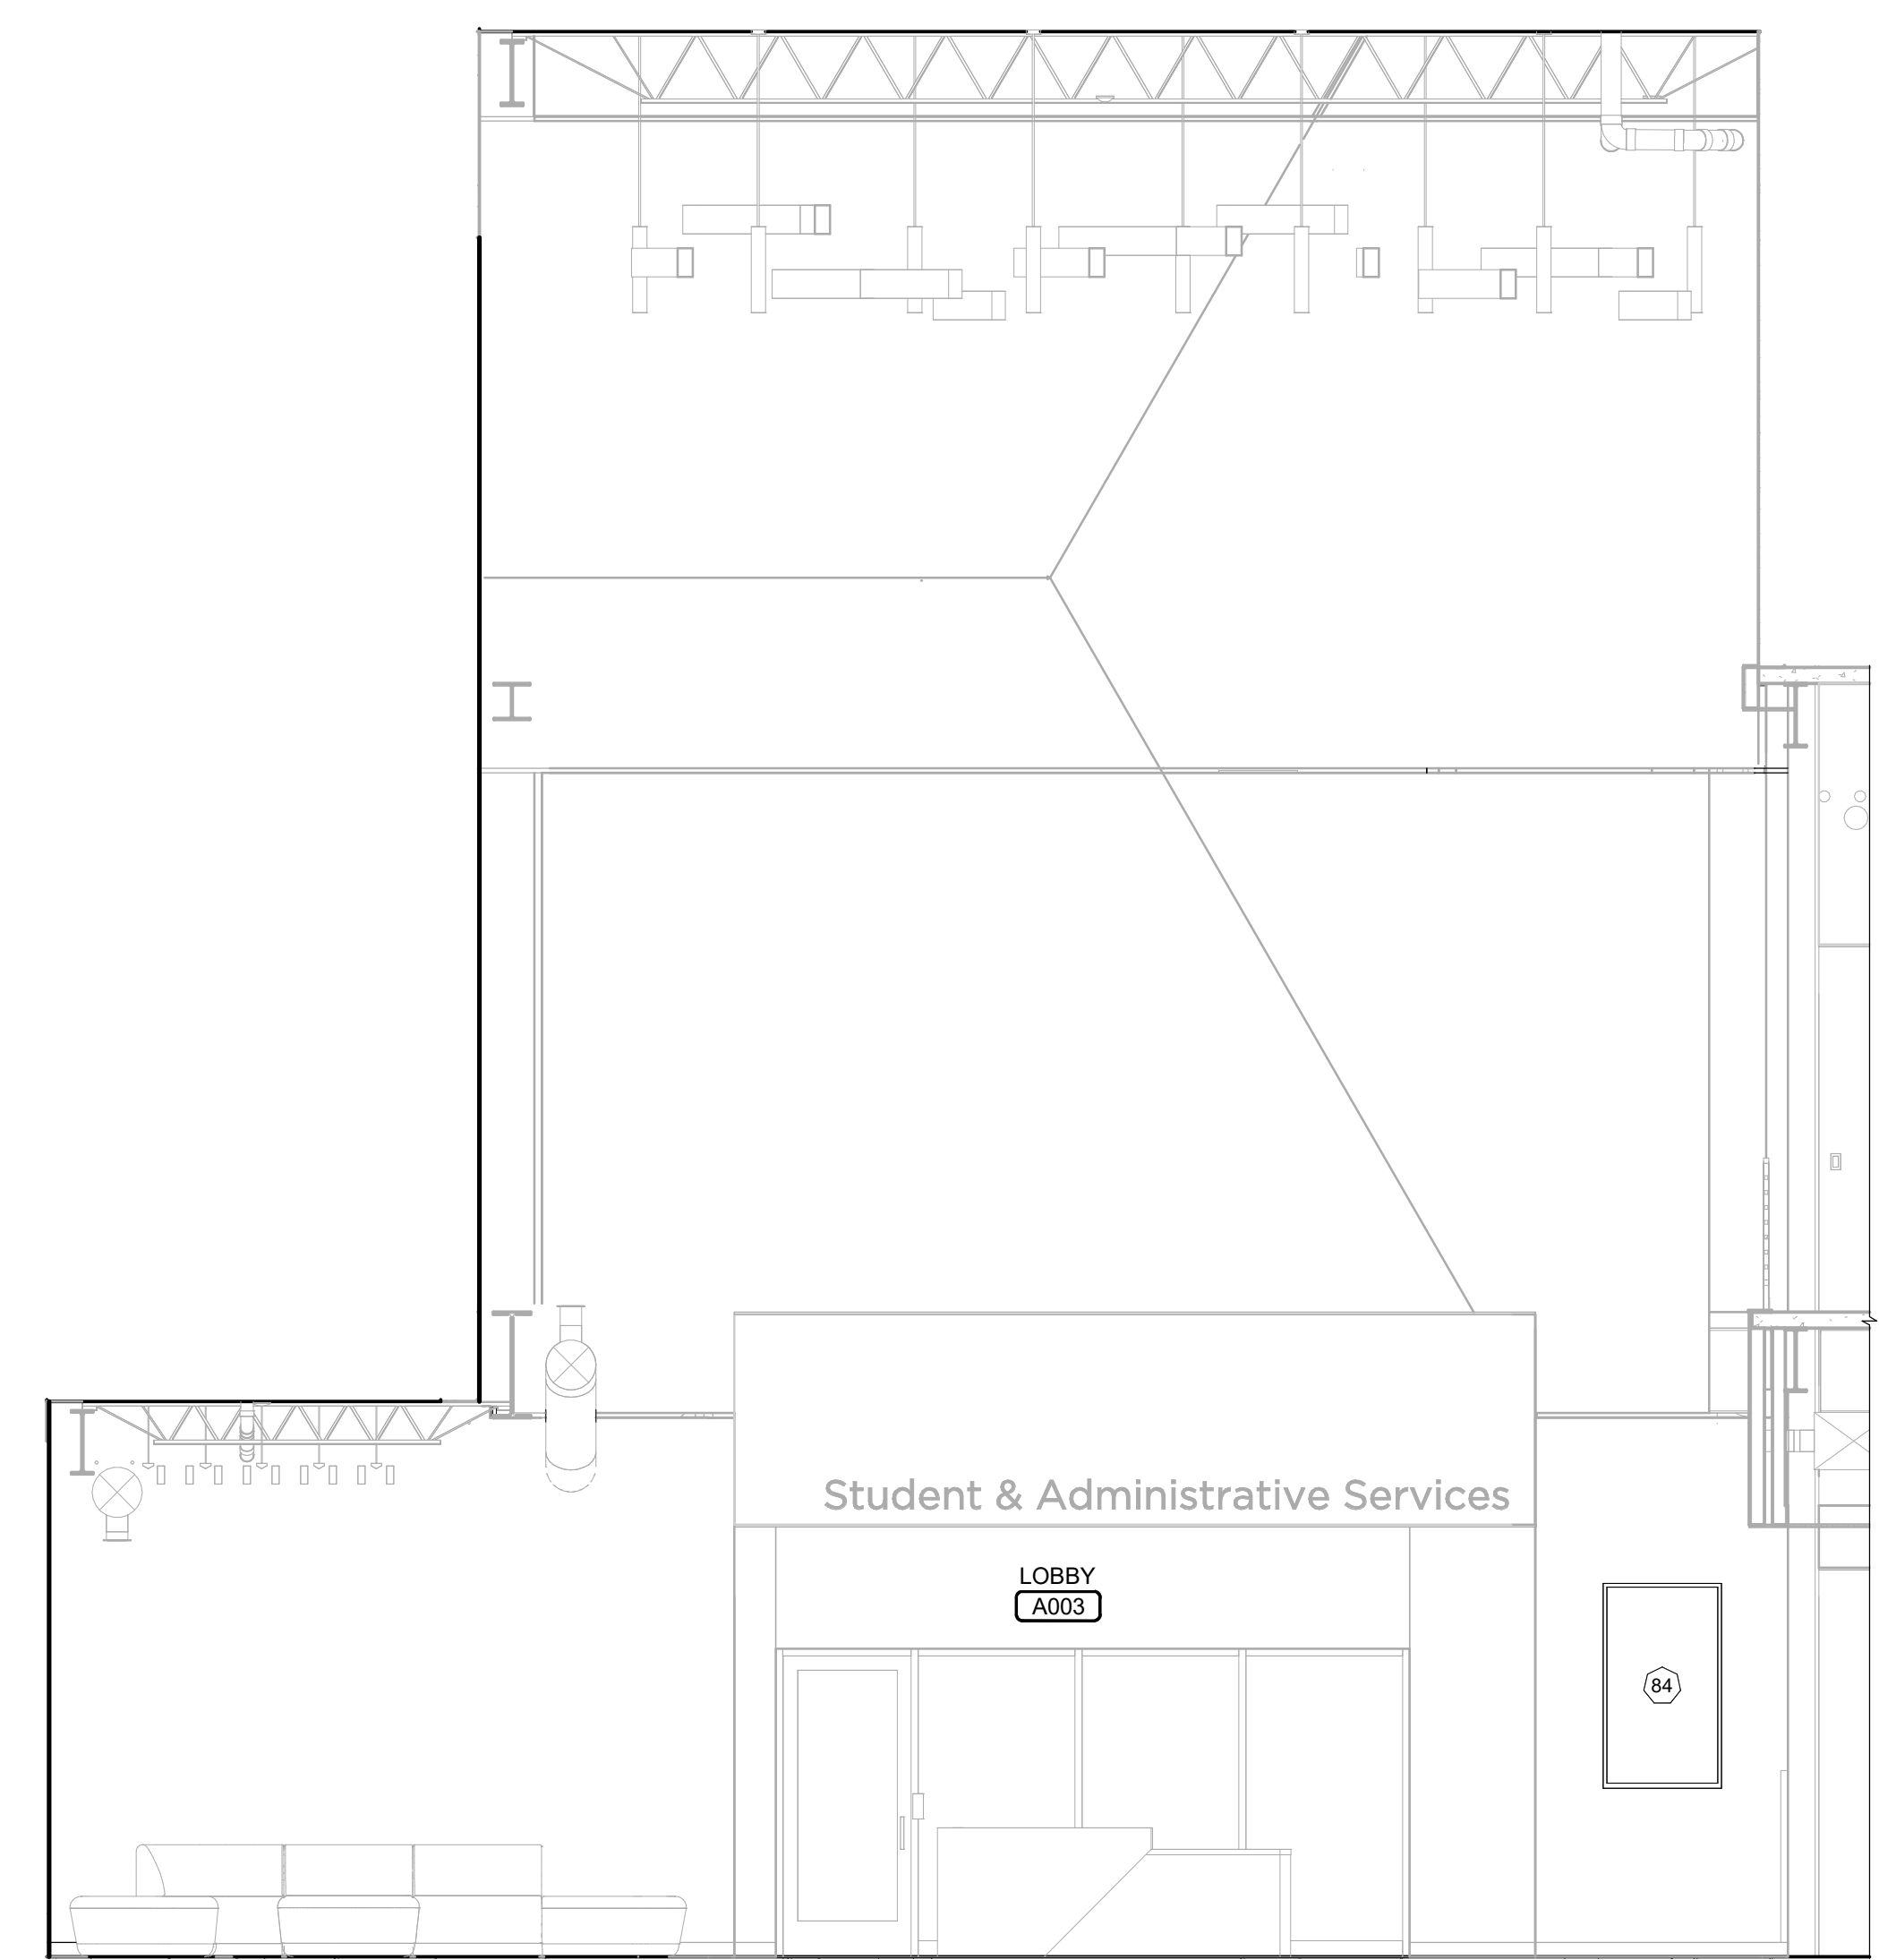


3 LOBBY ELEVATION
AT1.3 SCALE: 1/4" = 1'-0"

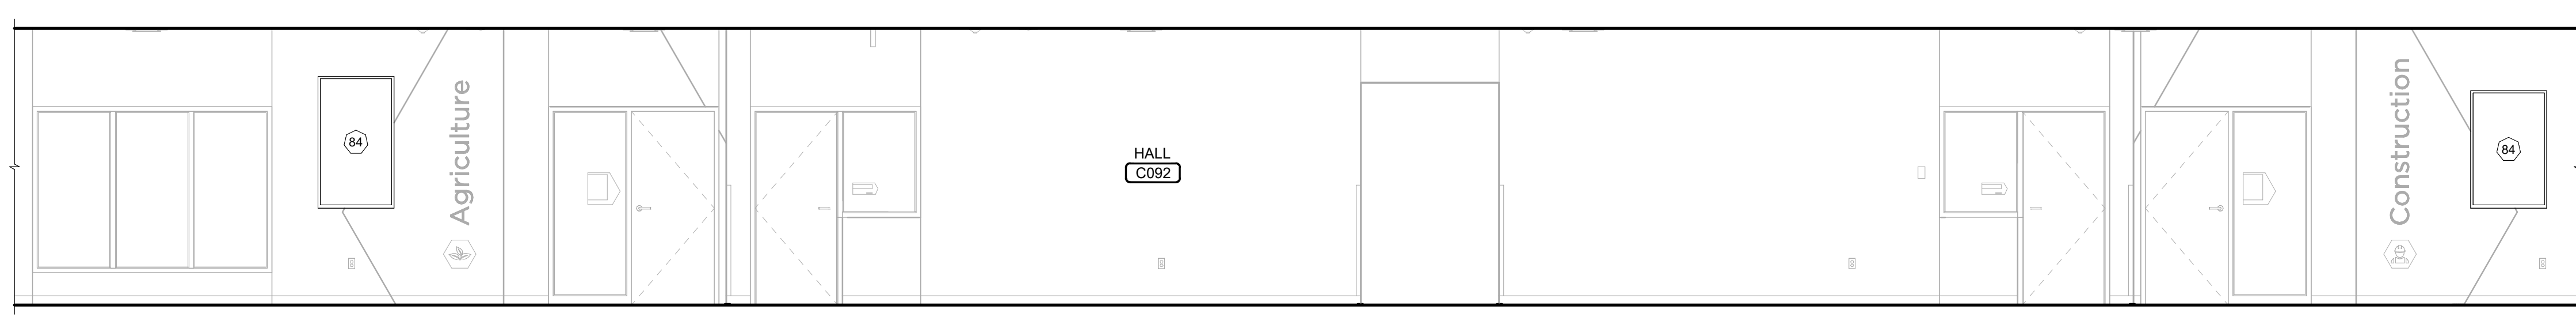

4 HALL ELEVATION
AT1.3 SCALE: 1/4" = 1'-0"

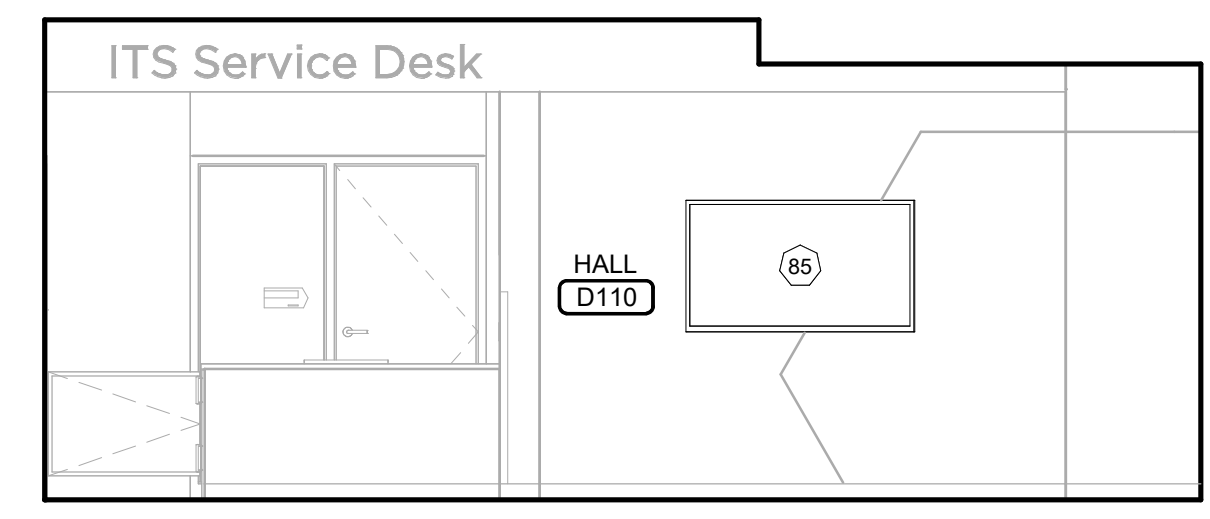

5 IT DESK ELEVATION
AT1.3 SCALE: 1/4" = 1'-0"

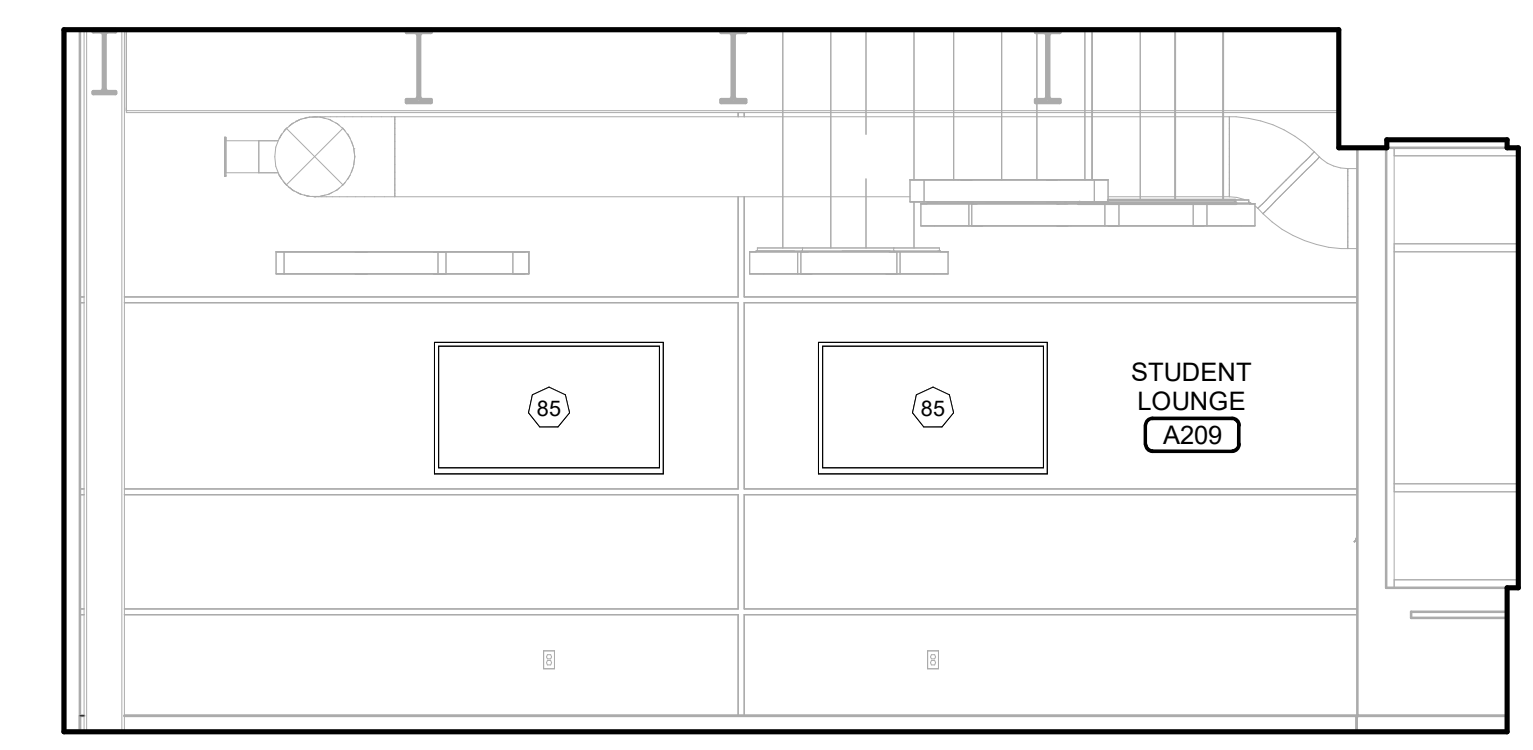

6 STUDENT LOUNGE ELEVATION
AT1.3 SCALE: 1/4" = 1'-0"

Read and understand Specification Divisions 00 & 01 and appropriate technical Specification Sections applicable to perform the work shown on this drawing sheet. Notify Architect/Engineer of any inconsistencies.

PROJECT #: FG2301FG
DATE: 12/18/2024
DRAWN BY: JRZ
CHECKED BY: KMR, RAW
© 2024 RLE

TECHNOLOGY ELEVATIONS